


MWCEA Conference on Education

September 20-23, 2020

Clarion Resort Fontainebleau Hotel - Grand Ballroom & Lobby - Level 1
Ocean City, MD



Show Information	
Show Name	MWCEA Conference on Education
Show Dates	September 20-23, 2020
Move-In	September 20, 2020
Job #	M238060919
AE	Frank Brown

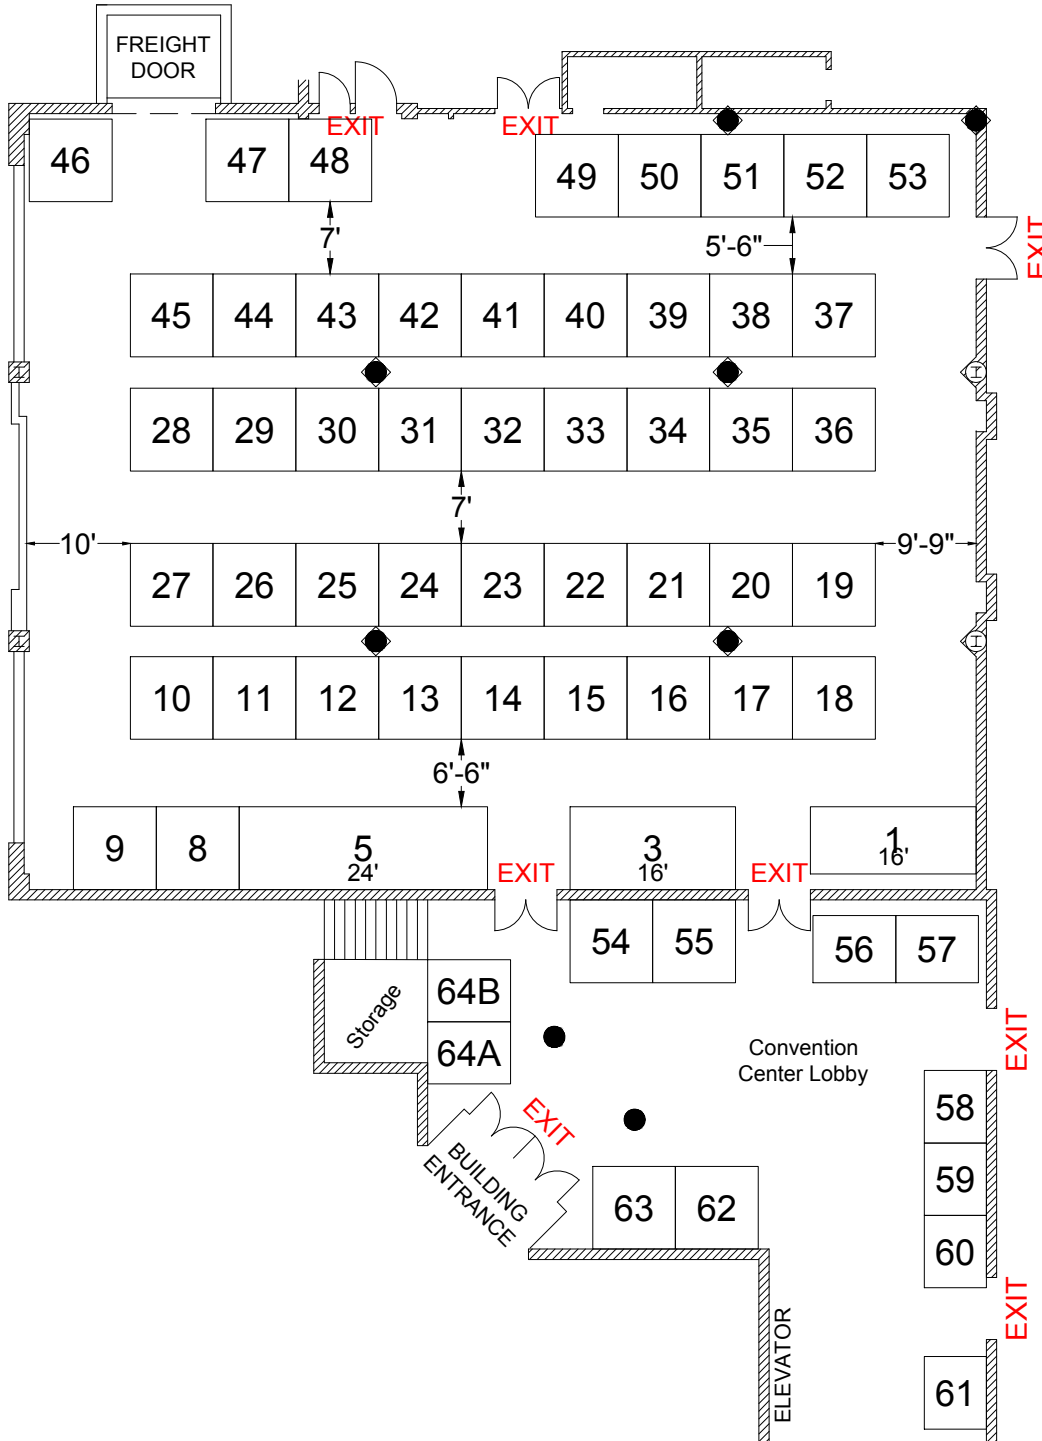

Inventory as of 09/27/2019

Dimension	Size	Qty	SqFt
6'x7'	42	4	168
6'x8'	48	2	96
6'-6"x8'	52	2	104
8'x8'	64	50	3,200
6'-6"x16'	104	1	104
8'x16'	128	1	128
8'x24'	192	1	192
Totals:	61		3,992

Floor Plan Legend

FE	Fire Extinguisher
FS	Fire Strobe
FHC	Fire Hose Cabinet

Venue Info

Building Name	Clarion Resort Fontainebleau Hotel
Hall	Grand Ballroom & Lobby
Floor	Level 1
Address	10100 Coastal Highway Ocean City, MD 21842

Drawing Information

File Path	J:\01_Floor Plans_01_SE3_SHOW_FLOORPLANS\02\010_Shepard\MWCEA Conference on Education_M238060919.dwg
File Name	MWCEA Conference on Education_M238060919.dwg
Drawn By	Jayson de Nieva
Last Saved	9/27/2019 3:31 PM
Saved By	Jdenieva
Tab	Floorplan
Paper Size	ANSI full bleed A (11.00 x 8.50 Inches)
Scale	NTS

1531 Carroll Drive NW
Atlanta, GA 30318
(v) 404-720-8600
(f) 404-720-8750

Shepard Exposition Services has made every effort to ensure the accuracy of all information contained on this floor plan. However, no warranties, either expressed or implied, are made with respect to this floor plan. Verifying the locations of building columns, utilities, or other architectural components of the facility is the sole responsibility of the exhibitor/show management.

SUBJECT TO FIRE MARSHAL APPROVAL